


ELECTRICAL PLAN

The plan below is a typical electrical plan showing the location of installed electricals on the ceiling.

This is not required for all building approvals, however we may request one should your extension/renovation require electrical work.

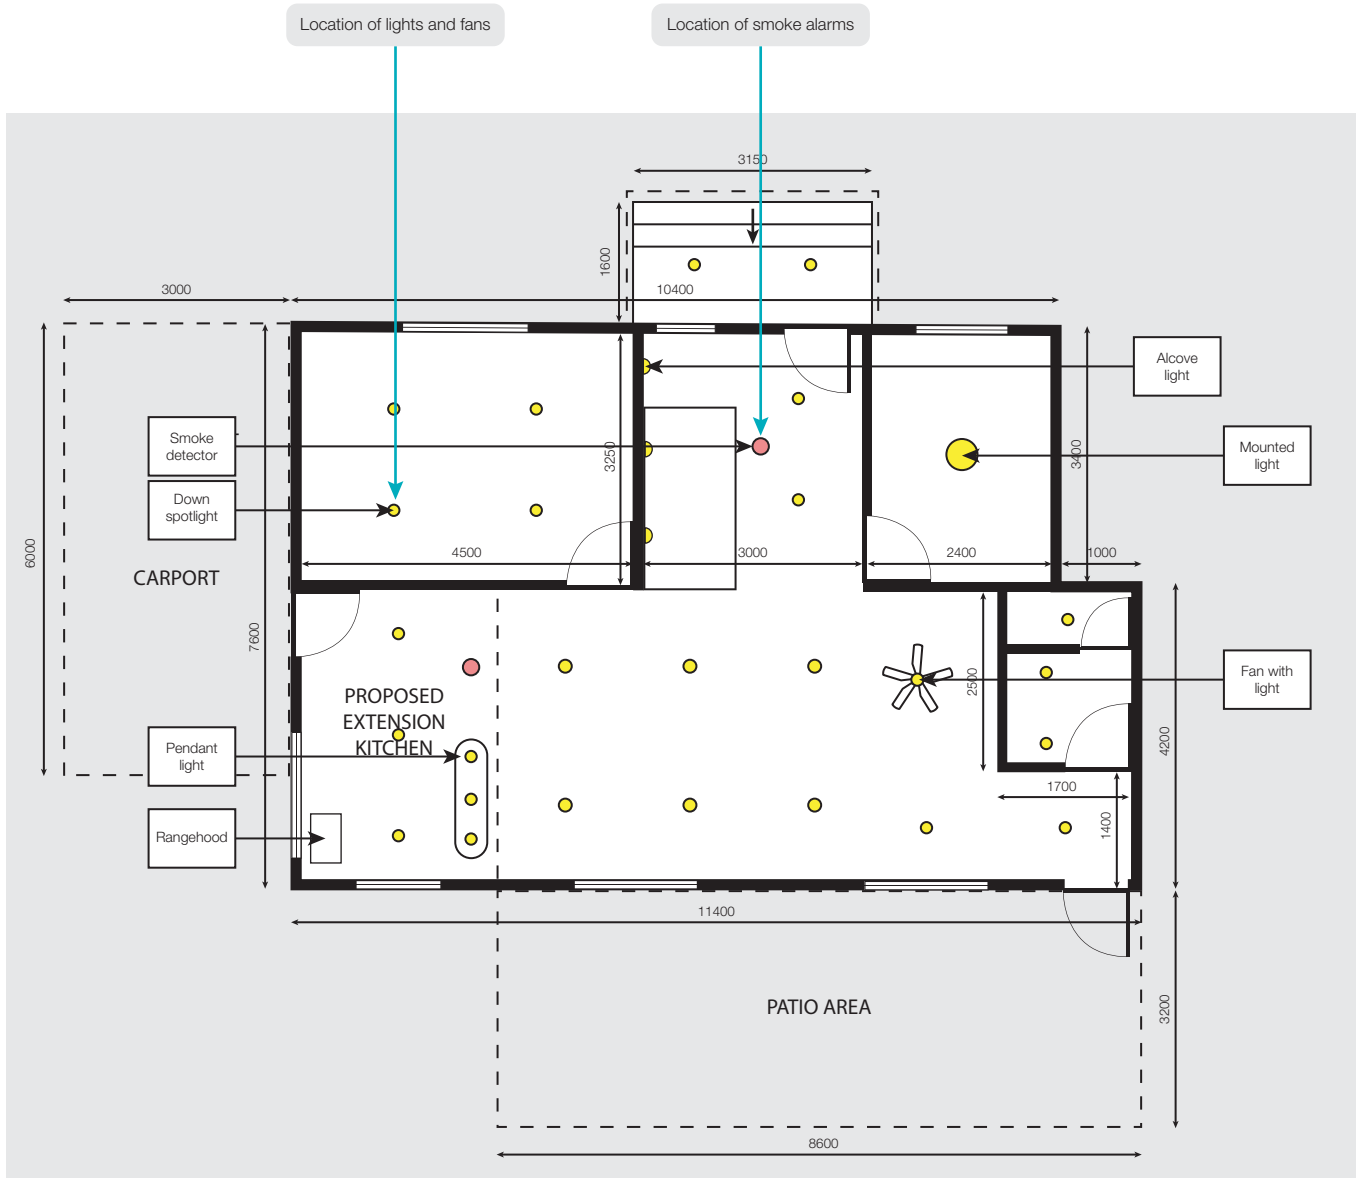

21 FLUID ST, ASPLEY QLD 4034	Drawn: John Applesseed Scale: 1:100
---------------------------------	--

Scale